

BFA+D
Woven Architecture™

Barbara Felix Architecture + Design

511 AGUA FRIA
SANTA FE, NM 87501
505-820-1555

Blake's LOTABURGER®

BLAKE'S LOTABURGER #65


RIO RANCHO, NM

XX.XX.XX

DRAWING INDEX

CODE	
G-000	TITLE SHEET
G-001	CODE PLAN, PROJECT DATA + BUILDING CODE ANALYSIS
G-002	CODE, GENERAL NOTES, ABBREVIATIONS + SYMBOLS
SURVEY	
SURVEY	PLAT OF TOPOGRAPHY
CIVIL	
C1	GRADING PLAN
C2	DRAINAGE PLAN
C3	GRADING + DRAINAGE PLAN
C4	UTILITY PLAN
C5	DETAILS PLAN
LANDSCAPE	
LS-101	LANDSCAPE PLAN
STRUCTURAL	
S-001	STRUCTURAL GENERAL NOTES
S-002	STRUCTURAL GENERAL NOTES
S-003	TYPICAL DETAILS
S-004	SPECIAL INSPECTIONS
S-101	FOUNDATION PLAN
S-102	ROOF FRAMING PLAN
S-103	PARAPET BRACING PLAN
S-301	SECTIONS
S-302	SECTIONS
S-303	SECTIONS
ARCHITECTURAL	
AS-100	DEMOLITION SITE PLAN
AS-101	ARCHITECTURAL SITE PLAN
AS-102	ARCHITECTURAL SITE DETAILS
AS-103	ARCHITECTURAL SITE DETAILS
A-100	FLOOR PLAN - DIMENSIONED
A-101	FLOOR PLAN - NOTED
A-110	REFLECTED CEILING PLAN
A-121	ROOF PLAN
A-201	ELEVATIONS - EXTERIOR
A-202	ELEVATIONS - EXTERIOR
A-210	ELEVATIONS - INTERIOR
A-211	ELEVATIONS - INTERIOR
A-212	ELEVATIONS - INTERIOR + BATHROOM ACCESSORIES
A-301	SECTIONS - BUILDING
A-302	SECTIONS - BUILDING
A-310	SECTIONS - WALL
A-311	SECTIONS - WALL
A-312	SECTIONS-WALL
A-401	ENLARGED PLAN + SCHEDULE - KITCHEN EQUIPMENT
A-402	ENLARGED PLANS - SIGNAGE AND KITCHEN ACCESSORIES
A-501	DETAILS - DOOR + WINDOW
A-502	DETAILS - ARCHITECTURAL
A-503	DETAILS - ARCHITECTURAL
A-510	DETAILS - MILLWORK
A-511	DETAILS - MILLWORK
A-601	SCHEDULES + TYPES - DOOR + WINDOW
A-610	FINISH PLAN + SCHEDULE
A-611	FINISH SCHEDULE + DETAILS
A-701	SIGNAGE
AI-100	FURNITURE PLAN & SCHEDULE
MECHANICAL	
M-001	MECHANICAL GENERAL NOTES AND LEGEND
M-101	MECHANICAL FLOOR PLAN
M-301	MECHANICAL ROOF PLAN
M-501	MECHANICAL DETAILS
M-502	MECHANICAL DETAILS
M-601	MECHANICAL DIAGRAMS AND SCHEDULE
ELECTRICAL	
SE-101	SITE ELECTRICAL PLAN
E-001	ELECTRICAL GENERAL NOTES AND LEGEND
E-101	ELECTRICAL LIGHTING FLOOR PLAN
E-201	ELECTRICAL POWER AND SPECIAL SYSTEMS FLOOR PLAN
E-301	MECHANICAL POWER FLOOR PLAN
E-501	ELECTRICAL DETAILS
E-601	ELECTRICAL DIAGRAMS AND SCHEDULES
UTILITIES	
SU-101	SITE UTILITY PLAN
PLUMBING	
P-001	PLUMBING GENERAL NOTES AND LEGEND
P-101	PLUMBING WASTE AND VENT FLOOR PLAN
P-201	PLUMBING DOMESTIC WATER PLAN
P-301	PLUMBING SPECIAL SYSTEM AND NATURAL GAS FLOOR PLAN
P-302	PLUMBING ROOF PLAN
P-501	PLUMBING DETAILS AND DIAGRAMS
P-601	PLUMBING SCHEDULE
P-602	PLUMBING DIAGRAMS

VICINITY MAP

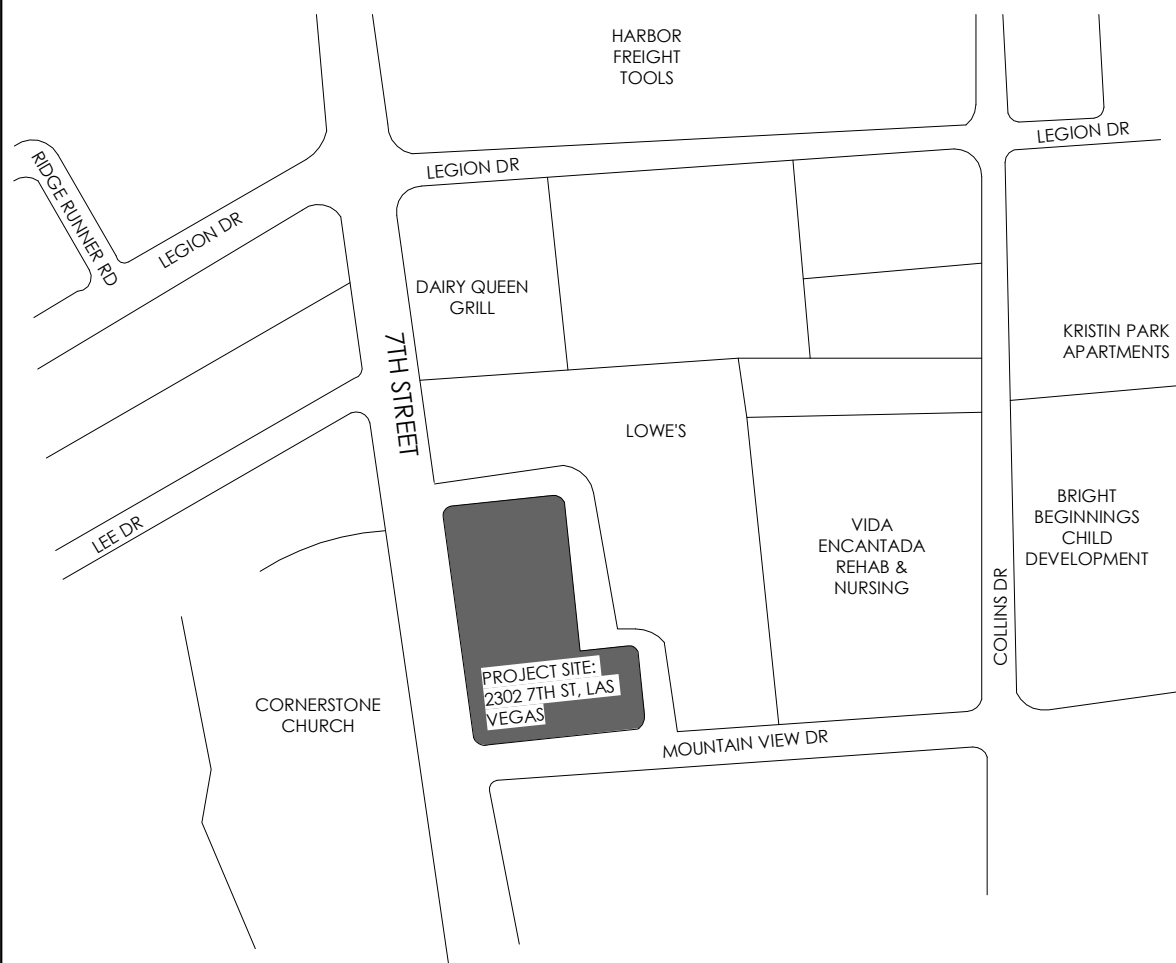

M.E.P. ENGINEERING

TIPTON ENGINEERING
427 LUISA PLACE
SANTA FE, NM 87505
(505) 310-3978

CIVIL ENGINEERING

WALKER ENGINEERING
905 CAMINO SIERRA VISTA
SANTA FE, NM 87505
(505) 820-7990

ARCHITECTURE AND INTERIOR DESIGN

BARBARA FELIX ARCHITECTURE + DESIGN
511 AGUA FRIA STREET
SANTA FE, NM 87501
(505) 820-1555

STRUCTURAL ENGINEERING

HIGH DESERT STRUCTURAL ENGINEERING
1911 5TH STREET, SUITE 205
SANTA FE, NM 87505
(505) 780-8897

GENERAL CONTRACTOR

BRYCON CORPORATION
8400 FIRESTONE LANE, NE
ALBUQUERQUE, NM 87113

GENERAL NOTES:

A. REFER TO SHEET G-001 FOR GENERAL NOTES, BUILDING CODE REFERENCES, BUILDING DATA AND ABBREVIATIONS.



All concepts, designs and plans directly or indirectly encompassed by this document are hereby copyrighted, and are for use on and in connection with the project specified in this document. None of such concepts, designs or plans shall be used by or disclosed to any person, firm or corporation without the prior written permission of Barbara Felix Architecture + Design, LLC.

KEY NOTES: THIS SHEET ONLY

01 ALIGN PANELS WITH NORTH SIDE OF TOWER

REFERENCE NOTES:

05 - METALS

05.50.04 AWNING
07.45.01 MINERAL-FIBER REINFORCED CEMENTITIOUS PANELS
07.62.01 PARAPET COPING, UNA-CLAD 24 GA. KYNAR 500, FLUOROCARBON STEEL, CITYSCAPE

07 - THERMAL & MOISTURE PROTECTION

07.62.02 DOUBLE TAPERED PARAPET COPING, UNA-CLAD 24 GA. KYNAR 500, FLUOROCARBON STEEL, CITYSCAPE
09.24.01 2-COAT PORTLAND CEMENT STUCCO SYSTEM
10.14.05 WALL-MOUNTED SIGNAGE "BLAKE'S" BY SIGNAGE CONTRACTOR

08 - GLAZING

09 - FINISHES

10 - SPECIALTIES

10.14.06 CURVED ALUMINUM CABINET + BOTTOM-MOUNT SIGNAGE "LOTABURGER" BY SIGNAGE CONTRACTOR
10.14.08 WALL-MOUNTED SIGNAGE "2302" BY SIGNAGE CONTRACTOR
22.05.01 GAS RISER/METER

22 - PLUMBING

22.14.04 DOWNSPOUT NOZZLE AND SCREEN FOR OVERFLOW DISCHARGE; JAY R. SMITH 1775 OR EQUAL
26.05.01 C/I/METER ENCLOSURE; SEE ELECTRICAL
26.56.01 EXTERIOR LIGHT SCOVCE


26 - ELECTRICAL

27 - COMMUNICATIONS


28 - ELECTRONIC SAFETY AND SECURITY

LEGEND:


STUCCO COLOR A
STUCCO COLOR B
CJ STUCCO CONTROL JOINT

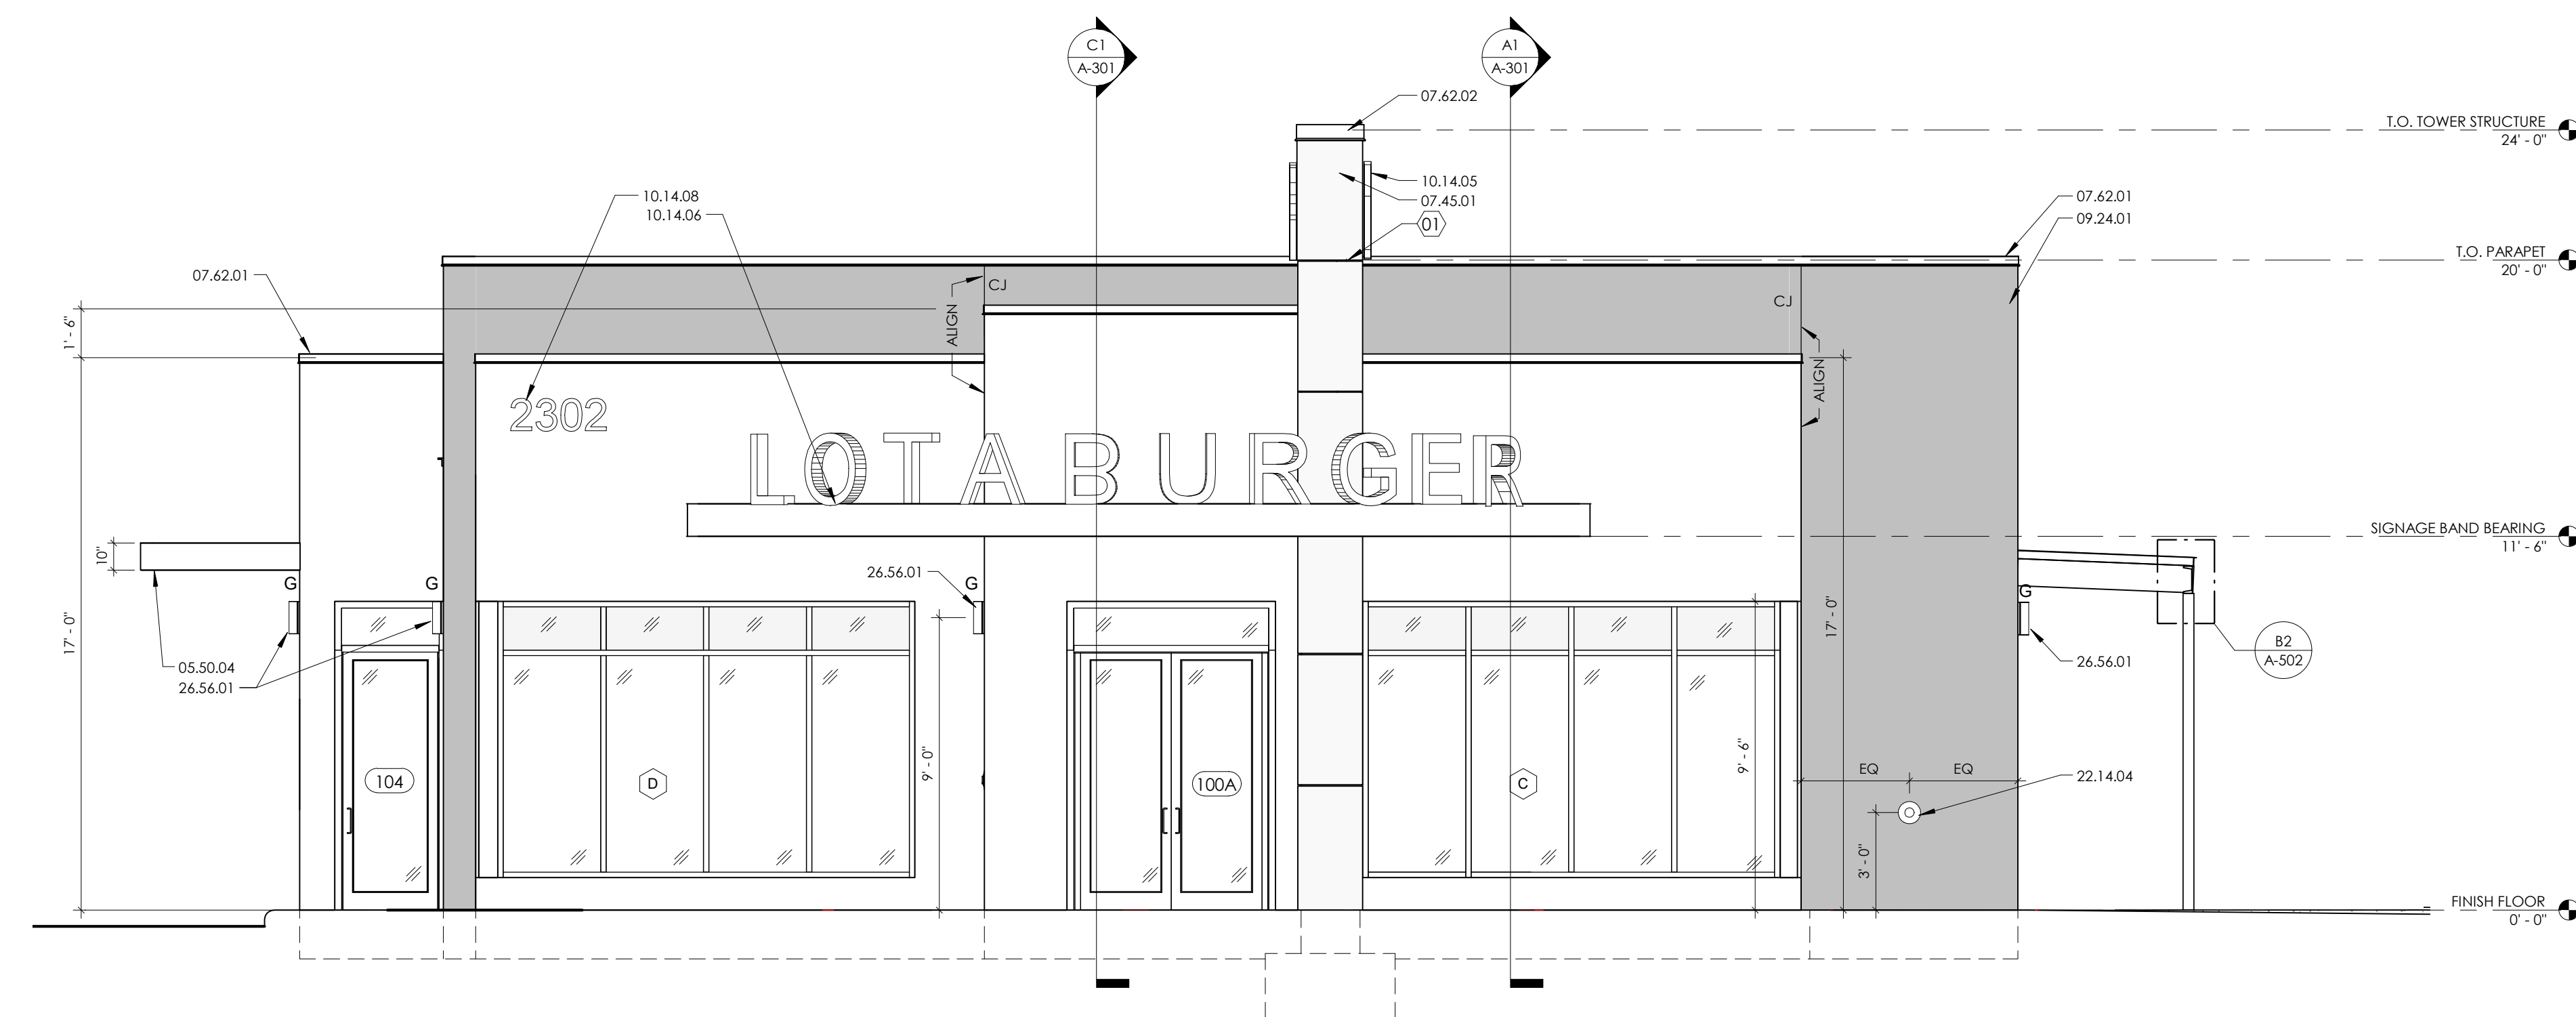

(C1) WEST ELEVATION
1/4" = 1'-0"

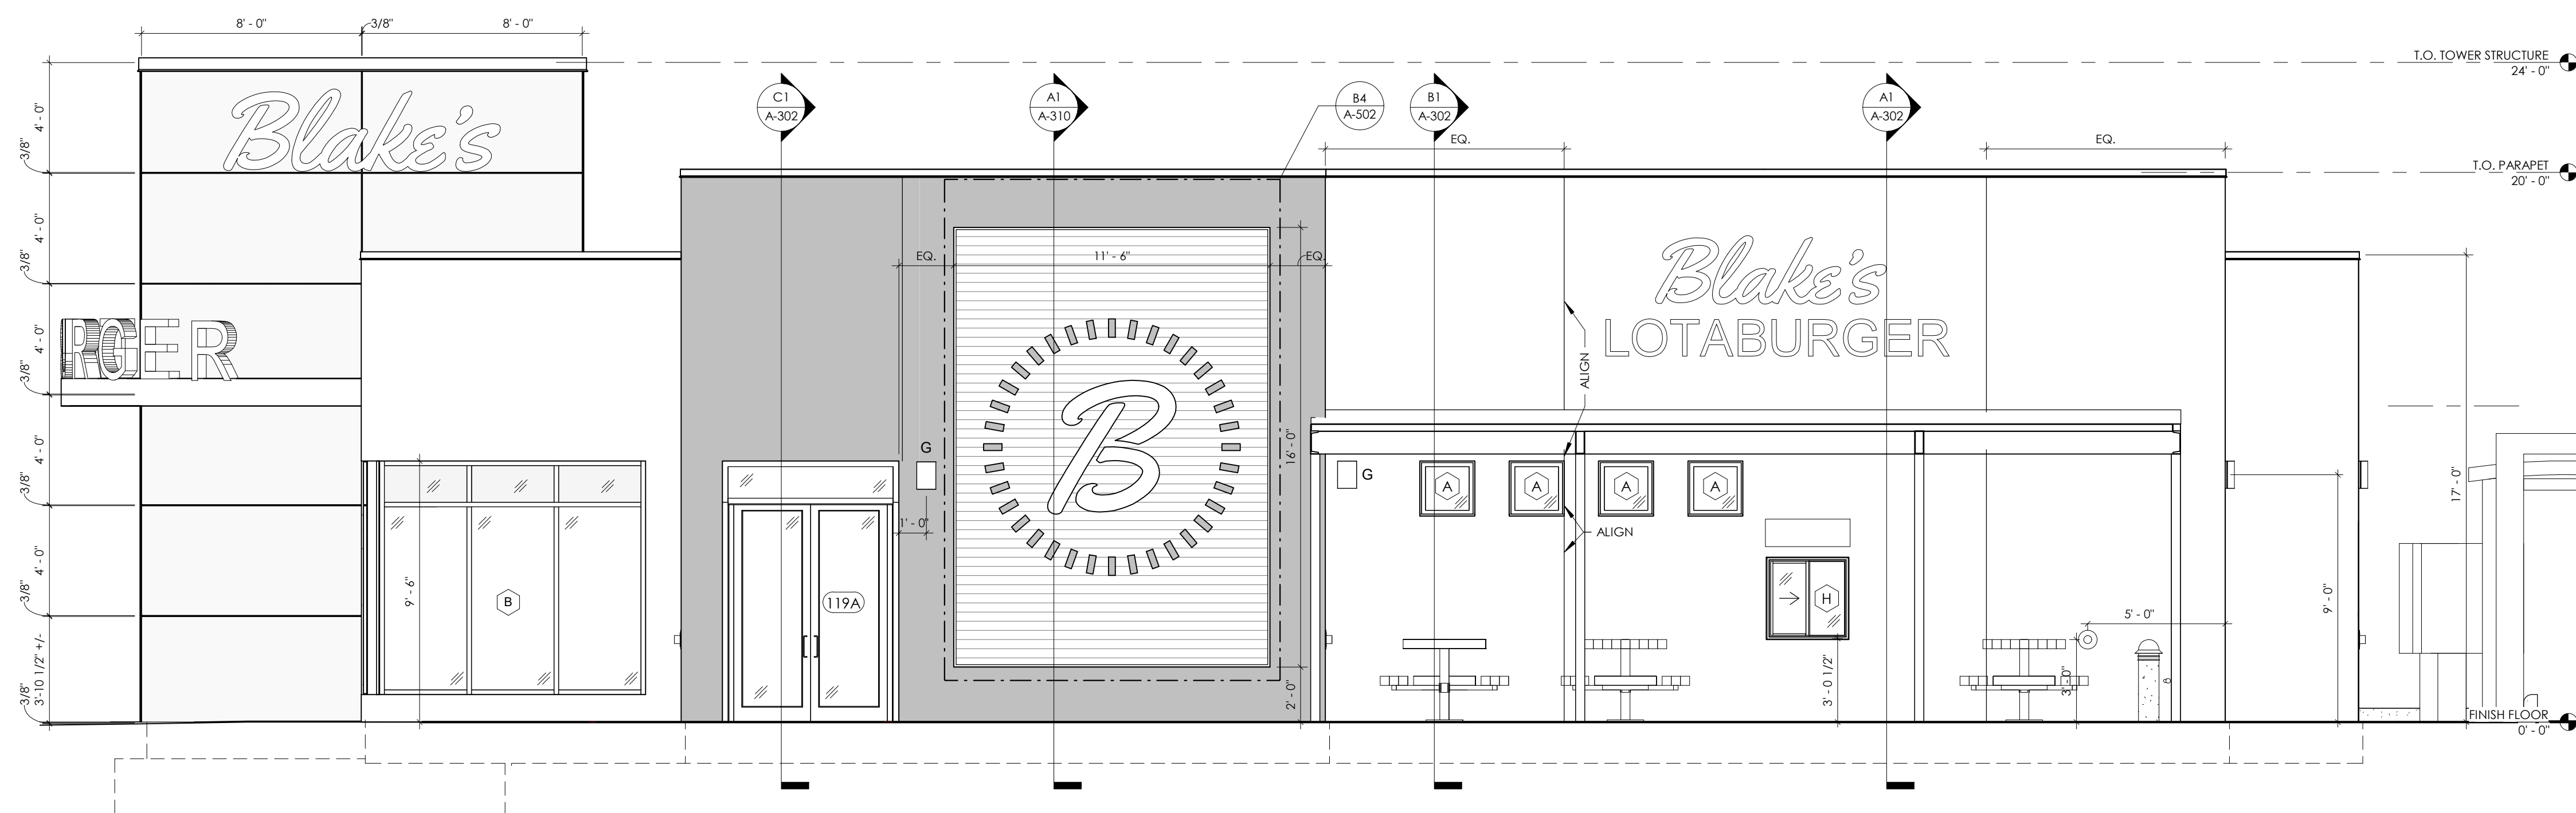

(A1) SOUTH ELEVATION
1/4" = 1'-0"

 

BLAKE'S
LOTABURGER #65
RIO RANCHO, NM

ISSUED		
MARK	DATE	DESCRIPTION

PROJECT NO	20013
FILE NAME	P:\Projects\18002_Blakes Lotaburger\Store #65
	(Rio Rancho)\10 Drawings\Sheet\Blakers #65_2002.rvt
DRAWN BY	BjF
CHECKED BY	BjF

Sheet Name
ELEVATIONS - EXTERIOR

Sheet No.

A-201
SHEET NO. ___ OF ___ SHEETS

All concepts, designs and plans directly or indirectly encompassed by this document are hereby copyrighted, and are for use on and in connection with the project specified in this document. None of such concepts, designs or plans shall be used by or disclosed to any person, firm or corporation without the prior written permission of Barbara Felix Architecture + Design, LLC.

KEY NOTES: THIS SHEET ONLY

01 PROVIDE SLEEVE FOR 2" WASTE OIL COLLECTION PORT. COORDINATE WITH OWNER'S VENDOR
02 ALIGN PANELS WITH NORTH SIDE OF TOWER

REFERENCE NOTES:

05- METALS
05.50.04 AWNING
07.45.01 MINERAL-FIBER REINFORCED CEMENTITIOUS PANELS



07- THERMAL & MOISTURE PROTECTION
07.62.01 PARAPET COPING, UNA-CLAD 24 GA. KYNAR 500, FLUOROCARBON STEEL, CITYSCAPE
07.62.02 DOUBLE TAPERED PARAPET COPING, UNA-CLAD 24 GA. KYNAR 500, FLUOROCARBON STEEL, CITYSCAPE
08.80.41 POLYCARBONATE GLAZING
22.05.01 GAS RISER/METER

08- GLAZING
22.14.04 DOWNSPOUT NOZZLE AND SCREEN FOR OVERFLOW DISCHARGE; JAY R. SMITH 1775 OR EQUAL

09- FINISHES
26.05.04 ELECTRICAL PANEL TYP. OF 3

10- SPECIALTIES
26.56.01 EXTERIOR LIGHT SCONCE

22- PLUMBING

26- ELECTRICAL

**BLAKE'S
LOTABURGER #65
RIO RANCHO, NM**

ISSUED	MARK	DATE	DESCRIPTION

LEGEND:

□ STUCCO COLOR A
■ STUCCO COLOR B
C-J STUCCO CONTROL JOINT

PROJECT NO.	20013
FILE NAME	P:\Projects\18002_Blakes Lotaburger\Store #65 Rio Rancho\1.0 Drawings\Sheet\Blages #65_2002.rvt
DRAWN BY	BJF
CHECKED BY	BJF
Sheet Name	ELEVATIONS - EXTERIOR
Sheet No.	A-202
SHEET NO.	___ OF ___ SHEETS

